


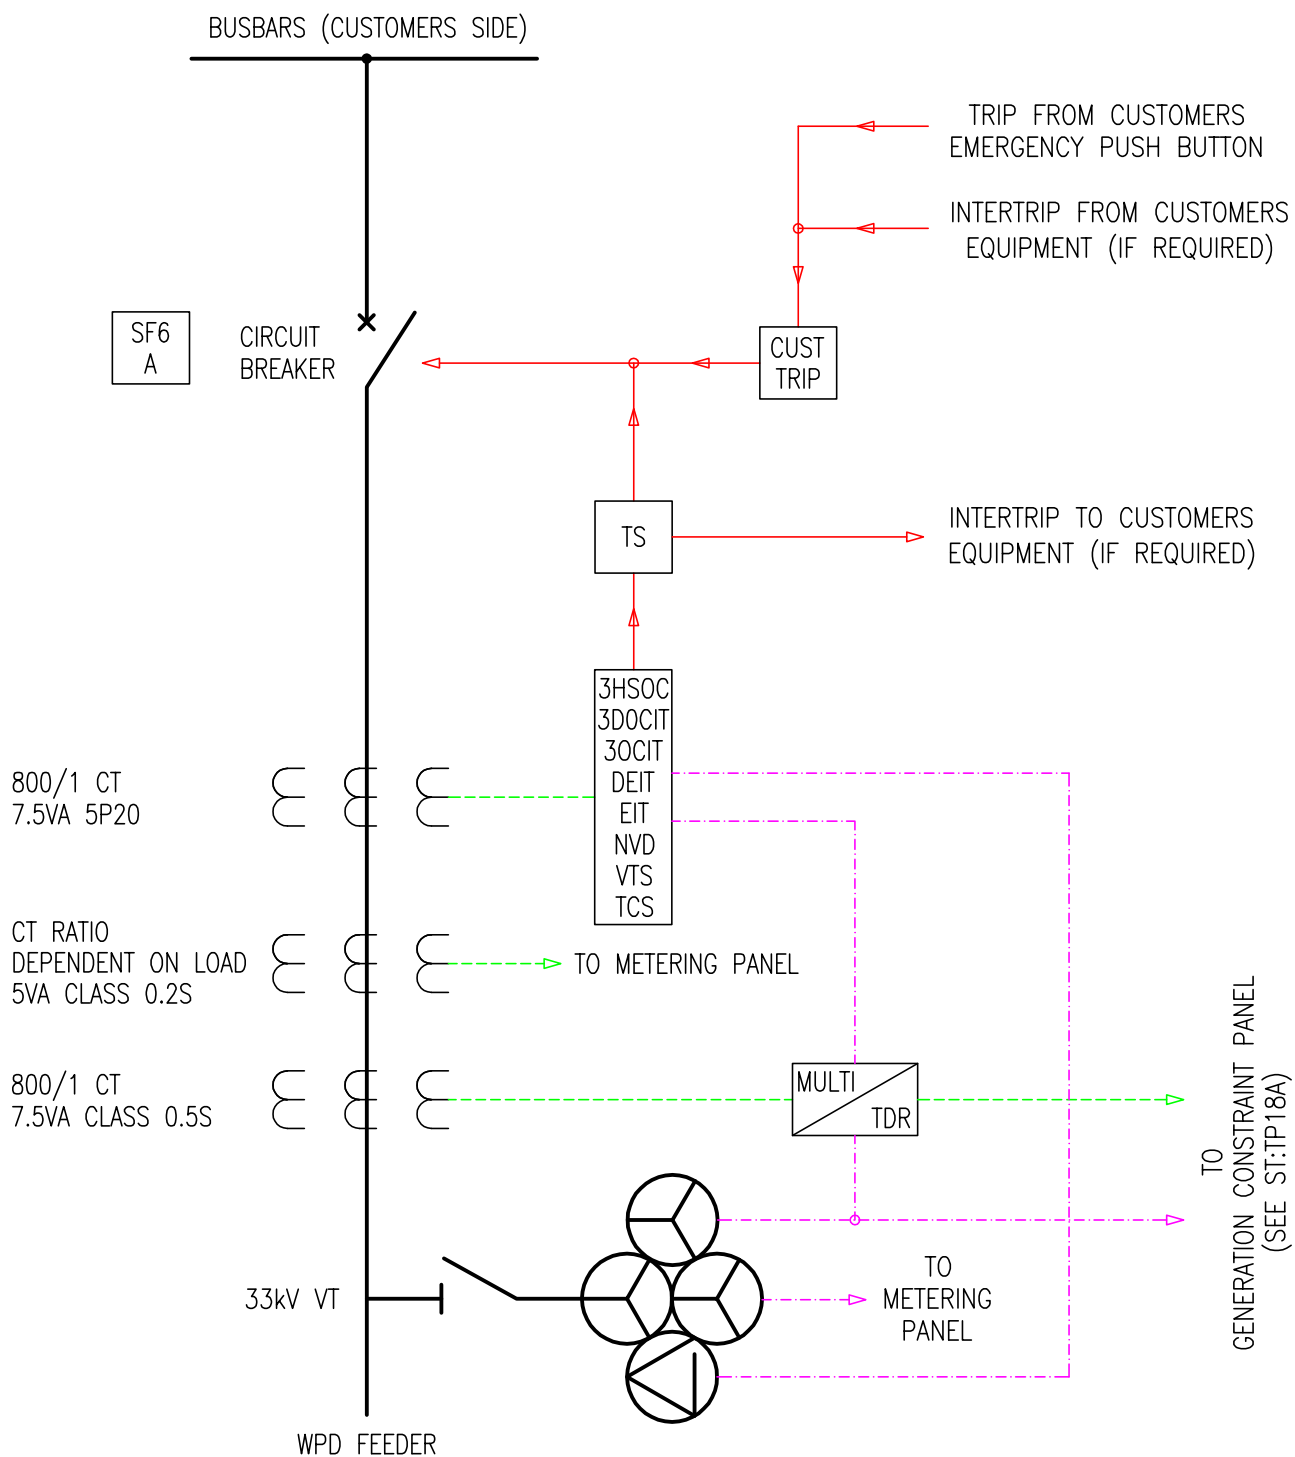

Rev No	Drawn	Chk'd	App'd	Date	Revision
ORIGINAL ISSUE		DATE		WESTERN POWER DISTRIBUTION Design Department. Avonbank, Feeder Road, Bristol BS2 OTB Tel: 0117 933 2000 Fax: 0117 933 2001. WESTERN POWER DISTRIBUTION 	
Drawn	CM	13/11/17			
Checked					
Approved					
SCALE		NTS		Title	
				SINGLE LINE DIAGRAM OF 36kV INCOMING CIRCUIT WITH METERING (1250A BUSBARS)	
				Drg. No.	
				SL36C11A	
				Rev No	